
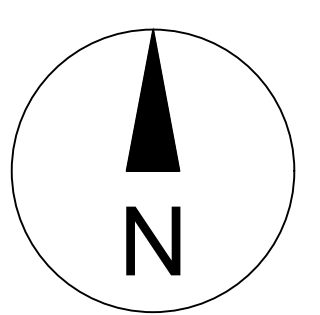


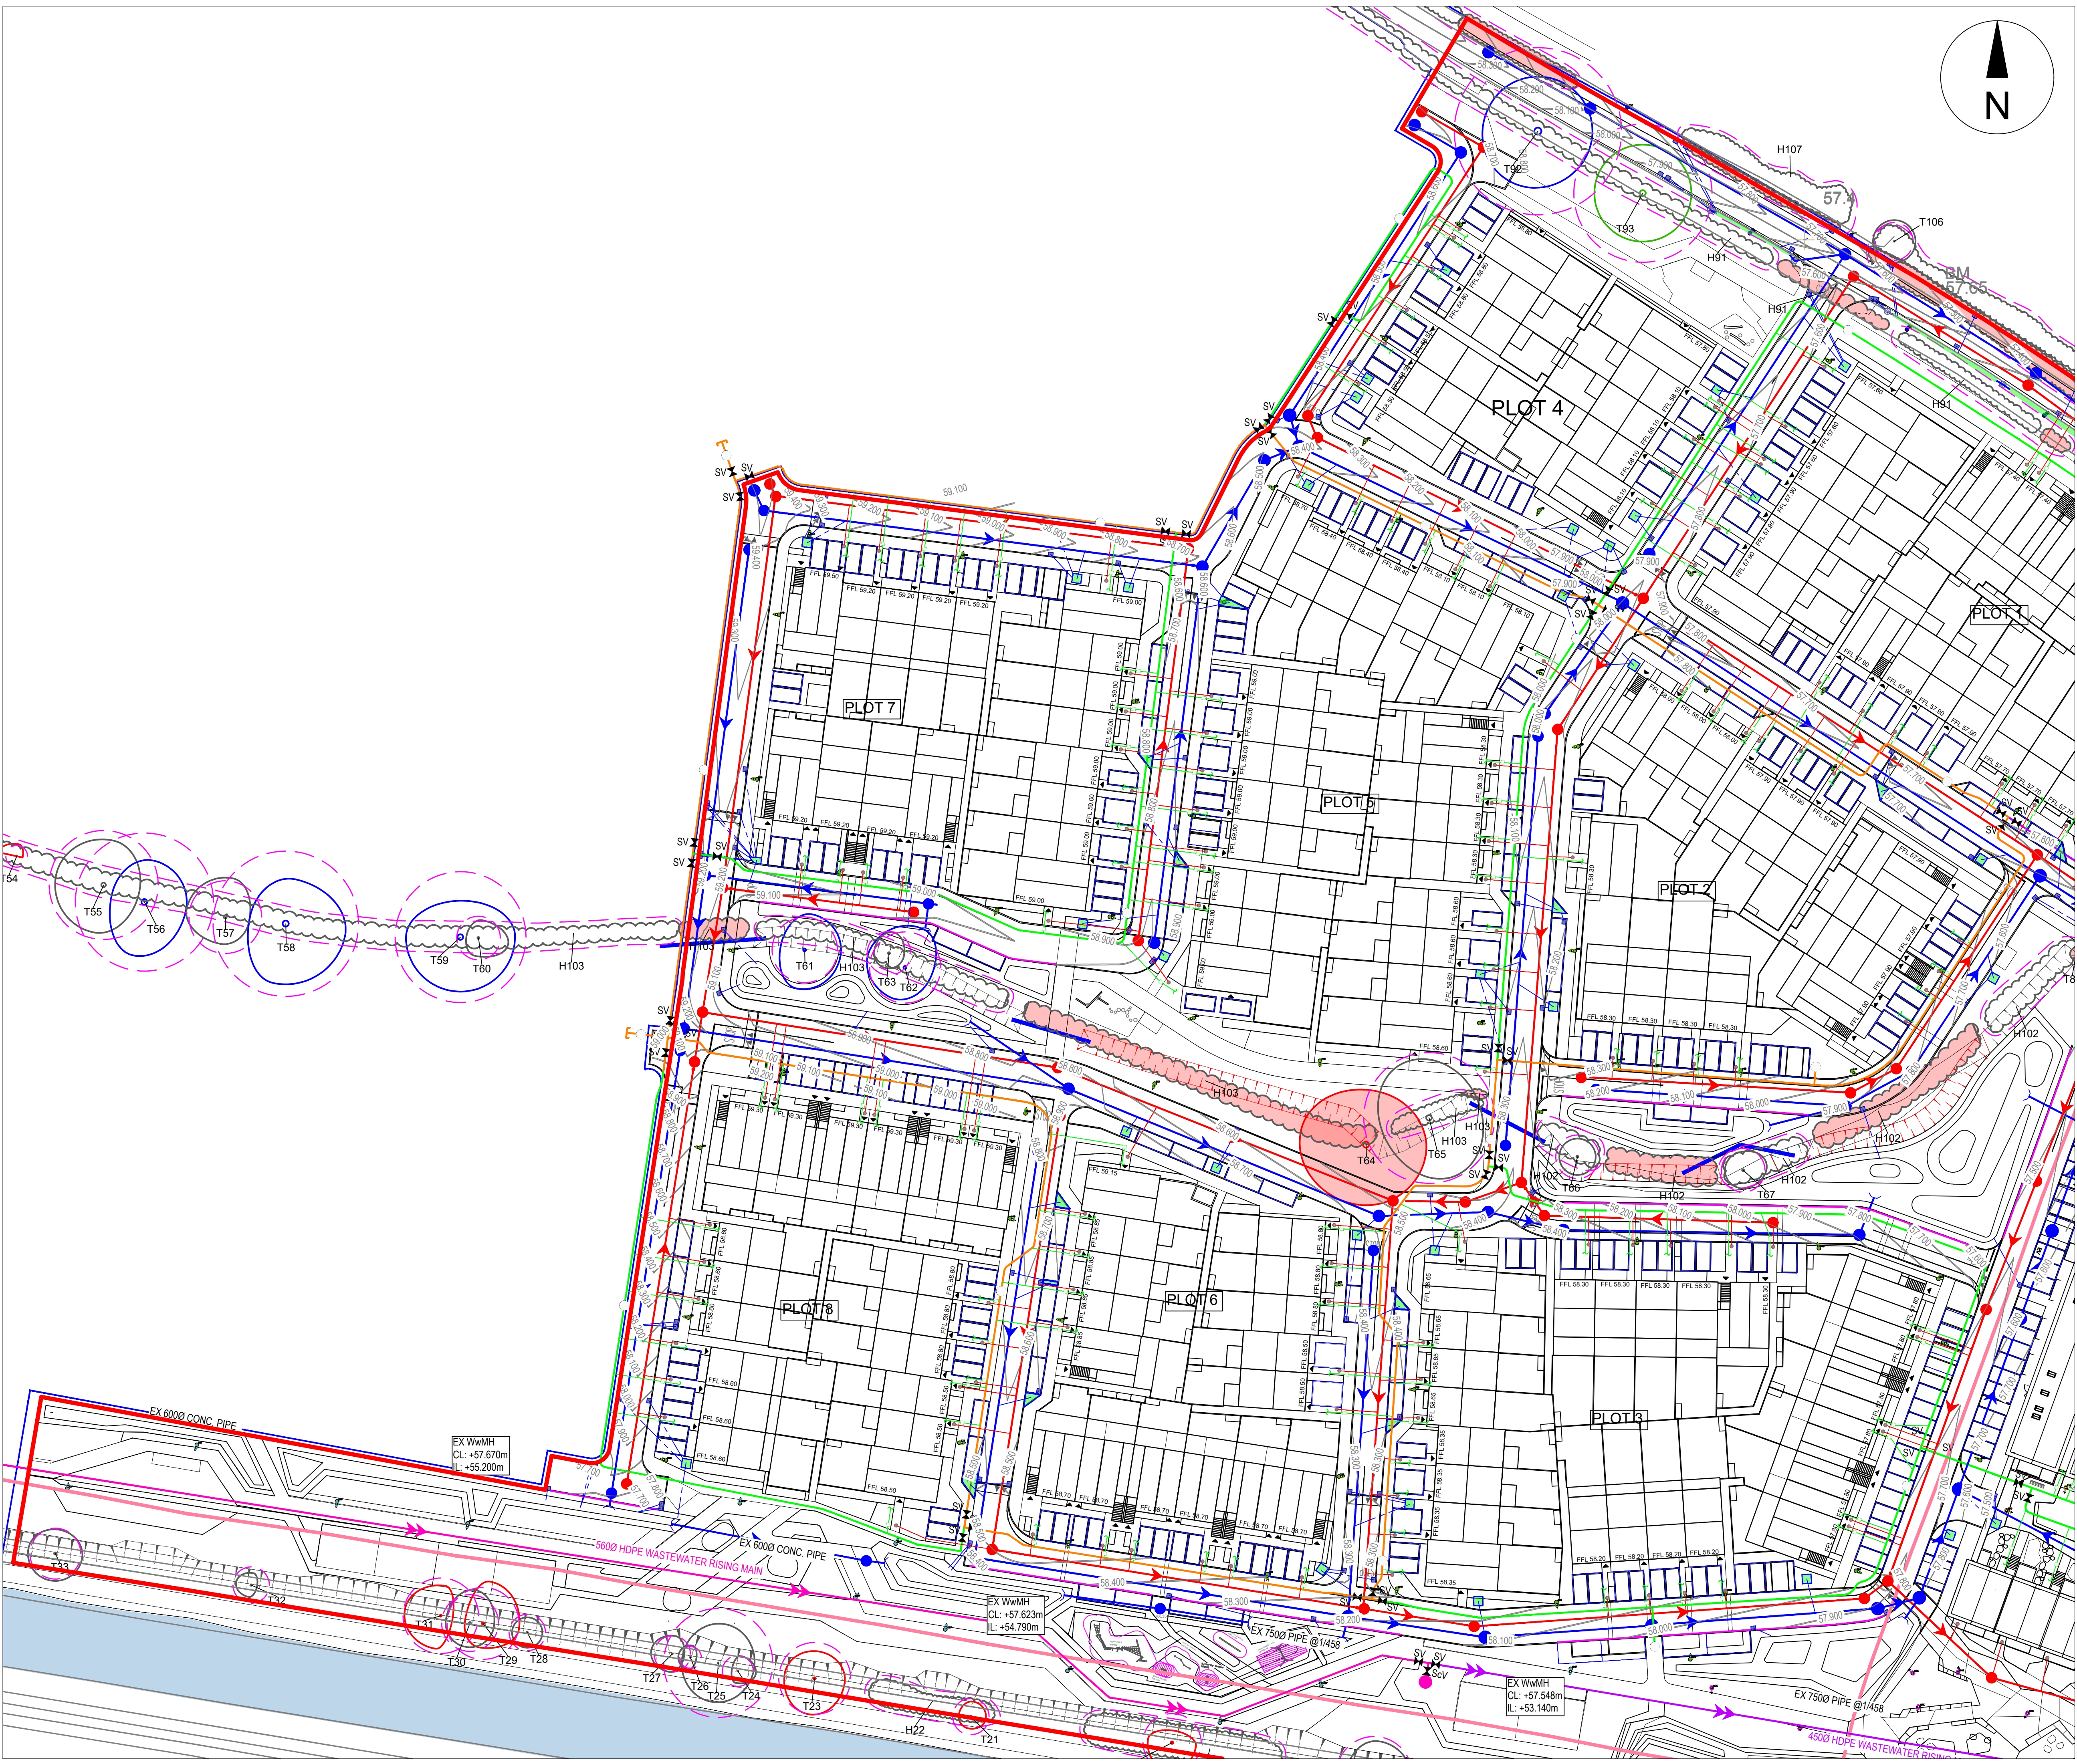

This drawing is to be read in conjunction with the respective arboricultural schedules and reports relevant to this project.

Where contradictions between this drawing and any other design information becomes apparent, the respective authors should be contacted immediately.

It is the responsibility of the main site contractor to check and verify all information and measurements onsite and confirm prior to the commencement of works, and to ensure that all site operatives work in accordance with respective arboricultural reports and BS5837:2012. Trees in relation to design, demolition and construction.

BS5837:2012 Tree Categorisation

Category A
Trees of high quality with an estimated remaining life expectancy of at least 40 years

Category B
Trees of moderate quality with an estimated life expectancy of at least 20 years

Category C
Trees of low quality with an estimated life expectancy of at least 10 years, or young trees with a stem diameter below 150mm

Category U
Those in such a condition that they cannot realistically be retained as living trees in the context of the current land use for longer than 10 years

Key

Root Protection Areas
The minimum area around a tree deemed to contain sufficient roots and rooting volume to maintain the trees viability

Tree, Shrub or Hedgerow Group

Reference Number for Tree, Group or Hedgerow

Site boundary


Trees to be Removed shown shaded RED

Group to be Removed shown shaded RED

Coppice hedgerow and interplant with native whips and install chestnut paling fence to protect shown shaded BLUE

Proposed Drainage Layout

Proposed site and levels in BLACK

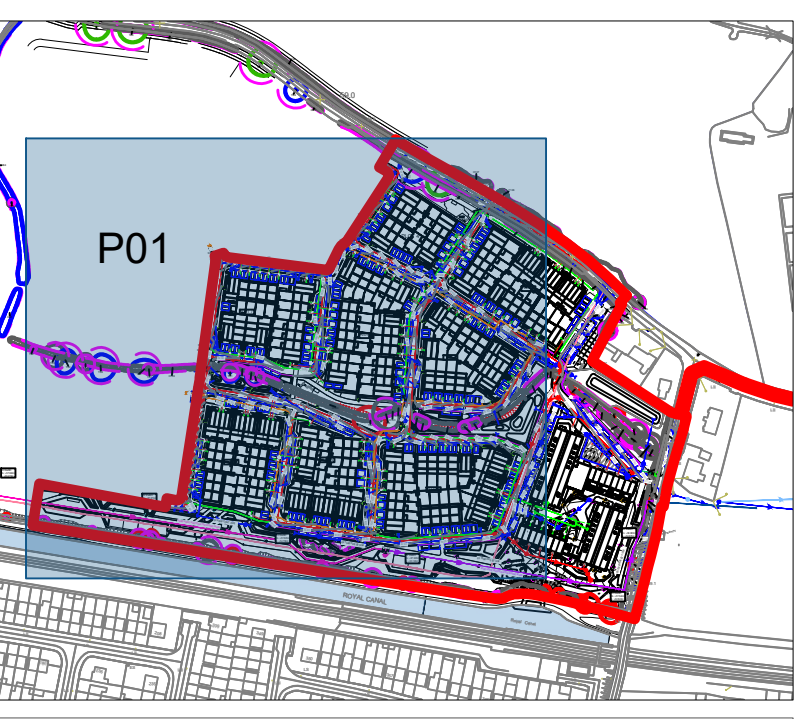

0 5m 10m 20m 30m 40m 50m		
A 02/06/26 Stage 3 Amendments		
Revision	Date	Description
Title:		
Tree Removals Plan 01		
Project:		
Confey Phase 1a LRD		
Client:		
Vanisland Limited		
Date:	22 May 2026	Scale: 1:500 @ A1
Drawn by:	NAPB	Status: Planning
Checked by:	CMcC	Dwg ref: 240920-P-11-01
		Rev: A
This drawing is the copyright of CM Arbor Ltd. has been produced for the client and project as stated above. The drawing may not be reproduced or amended, except by the written permission of CM Arbor Ltd. No liability will be accepted for any amendments made by other persons. ©		
CM Arbor Ltd. Arboricultural Consultants		
T: 085 843 7015 / E: charles@cmarbor.com / W: www.cmarbor.com		